



- LEGEND**
- 24" WIDE x 8" H" S.C.
 - 24" WIDE x 4" H" S.C.
 - SHOWS OPENING WITH GRD.
 - SHOULDER SLOPE AWAY
 - 4" x 4" x 16" S.C.
 - 6" x 6" x 16" S.C.

ELECTRICAL LEGEND

SYMBOL	DESCRIPTION	SYMBOL	DESCRIPTION
(Symbol)	SWITCH AND RECEPT	(Symbol)	OUTLET
(Symbol)	WALL SWITCH	(Symbol)	BOX CEMENT
(Symbol)	20A. BREAKER (CIRCUIT) FOR SWIRL WASTE	(Symbol)	BOX BRICK
(Symbol)	CONDUIT PLUMBING	(Symbol)	BOX BRICK FOR
(Symbol)	WALL SWITCH	(Symbol)	BOX BRICK FOR
(Symbol)	WALL SWITCH, RECEPT OR BOX	(Symbol)	BOX BRICK FOR
(Symbol)	WALL RECEPT, RECEPT	(Symbol)	BOX BRICK FOR
(Symbol)	SWITCH AND RECEPT	(Symbol)	BOX BRICK FOR
(Symbol)	SWITCH AND RECEPT	(Symbol)	BOX BRICK FOR
(Symbol)	SWITCH AND RECEPT	(Symbol)	BOX BRICK FOR
(Symbol)	SWITCH AND RECEPT	(Symbol)	BOX BRICK FOR

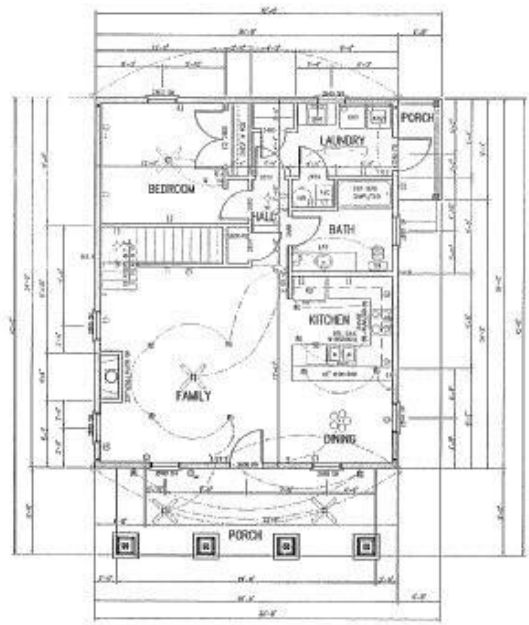

FIRST FLOOR PLAN
SCALE 1/4"=1'-0"

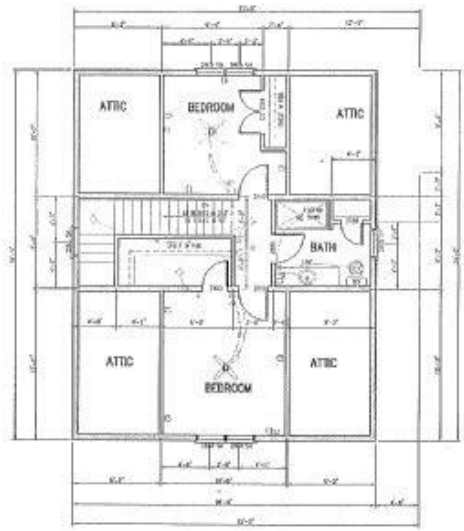

SECOND FLOOR PLAN
SCALE 3/8"=1'-0"

Prepared by
Mitch Baakley
Architect
1000 S. 10th St., Suite 100
Tampa, FL 33606
Tel: 813.288.1111

A NEW RESIDENCE FOR
COASTAL WALK PARTNERS
1000 S. 10th St., Suite 100
Tampa, FL 33606

DATE: 11/11/03
DRAWN BY: [Signature]
CHECKED BY: [Signature]
SCALE: AS SHOWN
SHEET NO.
FIRST & SECOND FLOOR PLAN